


**DISCLOSURE:**  
 ALL DIMENSIONS & SIZE DESIGNATIONS GIVEN  
 ARE SUBJECT TO VERIFICATION ON JOBSITE &  
 ADJUSTMENT TO FIT UNFORESEEN JOB  
 CONDITIONS. DESIGN PLANS ARE NOT PROVIDED  
 FOR ARCHITECTURAL OR ENGINEERING USE.

FENESTRATION SCHEDULE											
GLAZING (VERTICAL)											
WINDOW	SIZE	MANUFACTURER	MODEL	FUNCTION	QUANTITY	U-FACTOR	NFRC CERTIFIED	LOW-E	TEMPERED	EGRESS	
W1	4'0" X 3'0"	MILGARD	TRINSIC 2510	FIXED	1	.30	YES	YES	NO	NO	
W2	4'0" X 3'0"	MILGARD	TRINSIC 2510	DOUBLE CASEMENT	2	.30	YES	YES	NO	NO	
W3	6'4" X 3'6"	MILGARD	TRINSIC 2510	TRIPLE CASEMENT	1	.30	YES	YES	NO	NO	

- WALL LEGEND**
- NEW FINISHED WALLS
  - EXISTING WALLS
  - REMAIN EXISTING
  - PROPERTY LINES
- INTERIOR NOTES**
- DIMENSIONS ARE FROM FINISHED SURFACES UNLESS OTHERWISE NOTED.
  - ALL CABINETS & NISOS SHALL BE AS MANUFACTURED. SEE SPECIFICATIONS FOR ADDITIONAL FINISHES & MATERIALS.
  - CABINET DETAILS & DIMENSIONS ARE SUBJECT TO MANUFACTURER'S DIMENSIONS & FINISHES.
  - CABINET DETAILS & DIMENSIONS ARE SUBJECT TO MANUFACTURER'S DIMENSIONS & FINISHES.
  - ALL INTERIOR FINISHES SHALL BE AS MANUFACTURED. SEE SPECIFICATIONS FOR ADDITIONAL FINISHES & MATERIALS.
  - ALL DIMENSIONS ARE FROM FINISHED SURFACES UNLESS OTHERWISE NOTED.
  - VERIFY ALL DIMENSIONS & LOCATIONS BY MEASUREMENT PRIOR TO INSTALLATION.
- PAGE REFERENCE:**
- 10- COVER SHEET AND SITE PLAN
  - 11- EXTERIOR FINISHES
  - 12- INTERIOR FINISHES
  - 13- INTERIOR ELEVATIONS
  - 14- INTERIOR ELEVATIONS
  - 15- INTERIOR ELEVATIONS
  - 16- INTERIOR ELEVATIONS
  - 17- INTERIOR ELEVATIONS
  - 18- ELECTRICAL PLAN

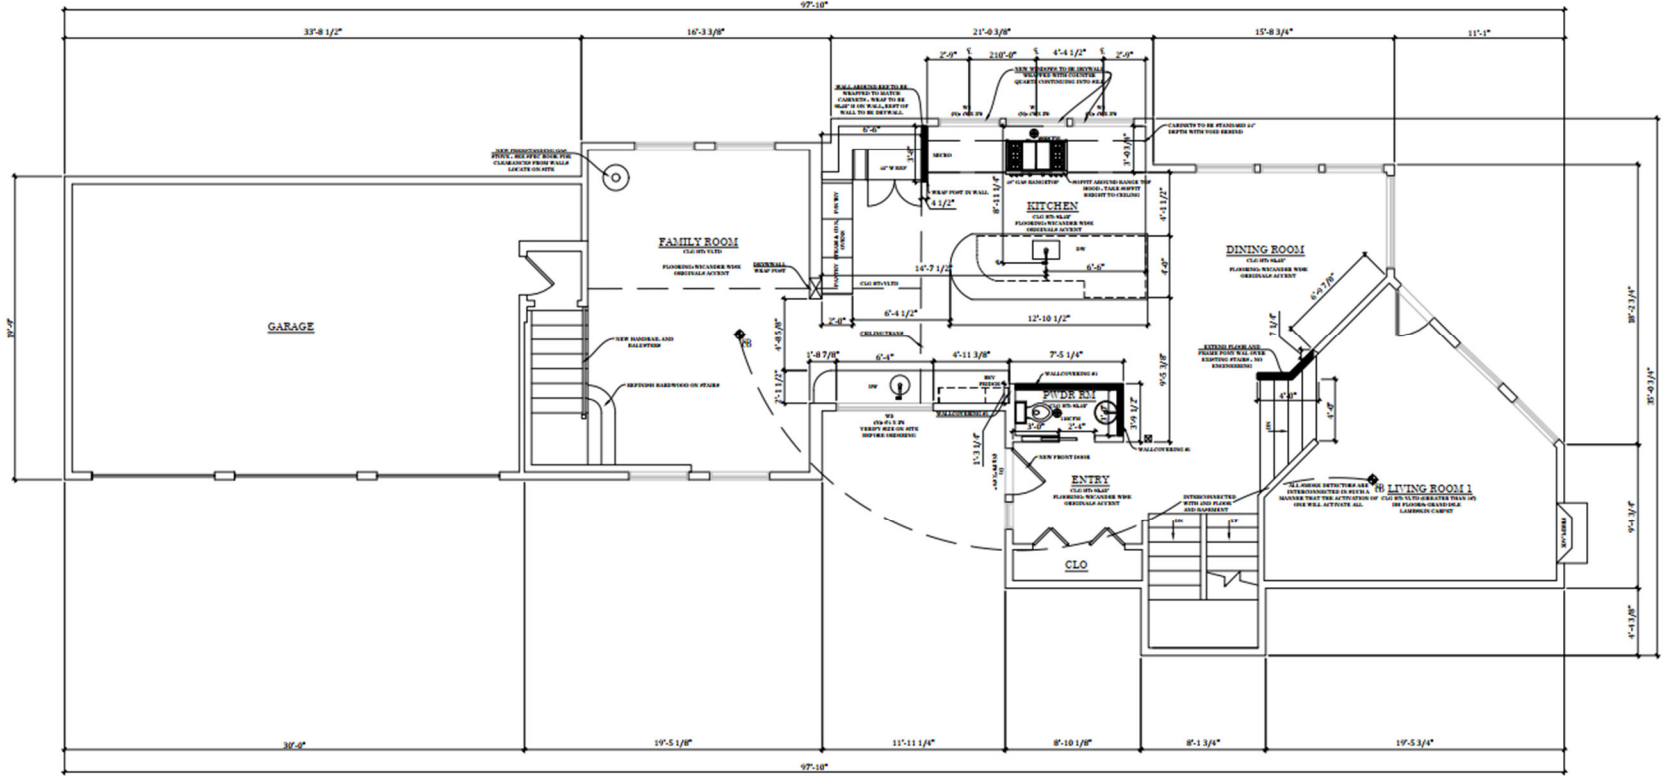

**NEW MAIN FLOOR PLAN**  
 SCALE: 1/8" = 1'-0"